




PATH & FILENAME: K:\GN\201001-00034\PROJECTS\DCR (3960\PROCESS\PIIDS\GCT01-242-0020-ZS-0000.DWG

JOB TITLE: NHC SHORT TERM SKETCH TITLE: NHC SHORT TERM DWP PIPELINE FEED TIE-IN P&ID										17 MAR. 2016 DOCUMENT CONTROL									
DATE: 22/05/2020 SCALE: NTS DRAWN: ZM VERIFIED: AD REASON FOR ISSUE: VALE NC REVIEW SOURCE OF BACKGROUND: 242-8820-25-0060										JOB No.: 6621325/451 SKETCH No.: XX REV: Z1_04 APPROVED: EG									
										NOTES 1. INTEGRER L'INSERTION A LA CUVE. INSERT TO BE PART OF TANK. 2. LA TIE-IN A L'AUTRE DE LA PIPE COMPORTE DEUX COUDS EN 90. SLURRY LINE USED 30 BENDS. 3. TIE-IN COMPLETED FOR TEMPORARY RLM CONVERSION OF 242-TNK-111 4. CARBON STEEL PIPELINE TO NEW PUMPS 5. REMOVE EXISTING 100X150 REDUCER									
										TITRE / TITLE P&ID PRECIPITATION HYDROXYDE MELANGE ZONE 242 RESERVOIRS DE STOCKAGE MHP MIXED HYDROXIDE PRECIPITATION AREA 242 MHP STORAGE TANKS									
										VALE NOUVELLE-CALÉDONIE SAS DISPOSE DE DROITS DE PROPRIÉTÉ ATTACHÉS AU PRÉSENT PLAN. CE DOCUMENT EST PRÊTÉ SANS AUTRE CONTREPARTIE DE LA PART DE L'EMPRUNTEUR QUE L'ASSURANCE QU'IL NE SERA PAS REPRODUIT, COPIÉ, PRÊTÉ OU ÉLIMINÉ DIRECTEMENT OU INDIRECTEMENT NI UTILISÉ POUR D'AUTRES RAISONS QUE CELLES POUR LEQUEL IL EST FOURNI, SAUF, LE CAS ÉCHÉANT, À BÉNÉFICIER DE L'AUTORISATION EXPRESSE DE VALE NOUVELLE-CALÉDONIE SAS. LA MISE À DISPOSITION DU PRÉSENT PLAN NE CONFÈRE AUCUNE CÉSSION DE DROITS DE PROPRIÉTÉ, TOTALE OU PARTIELLE. CERTAINS ÉLÉMENTS FIGURANT SUR LE PLAN SONT SUSCEPTIBLES D'ÊTRE BREVETÉS OU DE MARQUE DÉPOSÉE.									
										VALE NOUVELLE-CALÉDONIE SAS HAS INTELLECTUAL PROPERTY RIGHTS ATTACHED TO THIS DRAWING. THE DOCUMENT IS LOANED ON THE UNDERSTANDING THAT THE BORROWER SHALL AGREE NOT TO REPRODUCE, COPY, LEND OR DISPOSE OF, DIRECTLY OR INDIRECTLY, THE DOCUMENT OR USE FOR ANY OTHER PURPOSE OTHER THAN THAT FOR WHICH IT IS SPECIFICALLY INTENDED, SUBJECT TO VALE NOUVELLE-CALÉDONIE SAS'S PRIOR AGREEMENT. NO INTELLECTUAL PROPERTY RIGHTS ATTACHED TO THE DOCUMENT MAY BE TRANSFERRED, EITHER IN WHOLE OR IN PART. CERTAIN ELEMENTS SHOWN ON THE DOCUMENT MAY BE PATENTED OR REGISTERED TRADE MARKS.									
										VALE NOUVELLE-CALÉDONIE VALE NEW CALEDONIA									
										NUM. PROJ. / PROJECT No. PN 2652									
										NUM. REV. / REVISION No.									
										NUM. APP. / APPROVAL No.									
										NUM. SIGN. / SIGNATURE No.									
										NUM. DES. / DRAWING No.									
										NUM. VER. / CHECK No.									
										NUM. APP. / APPROVAL No.									
										NUM. SIGN. / SIGNATURE No.									
										NUM. DES. / DRAWING No.									
										NUM. VER. / CHECK No.									
										NUM. APP. / APPROVAL No.									

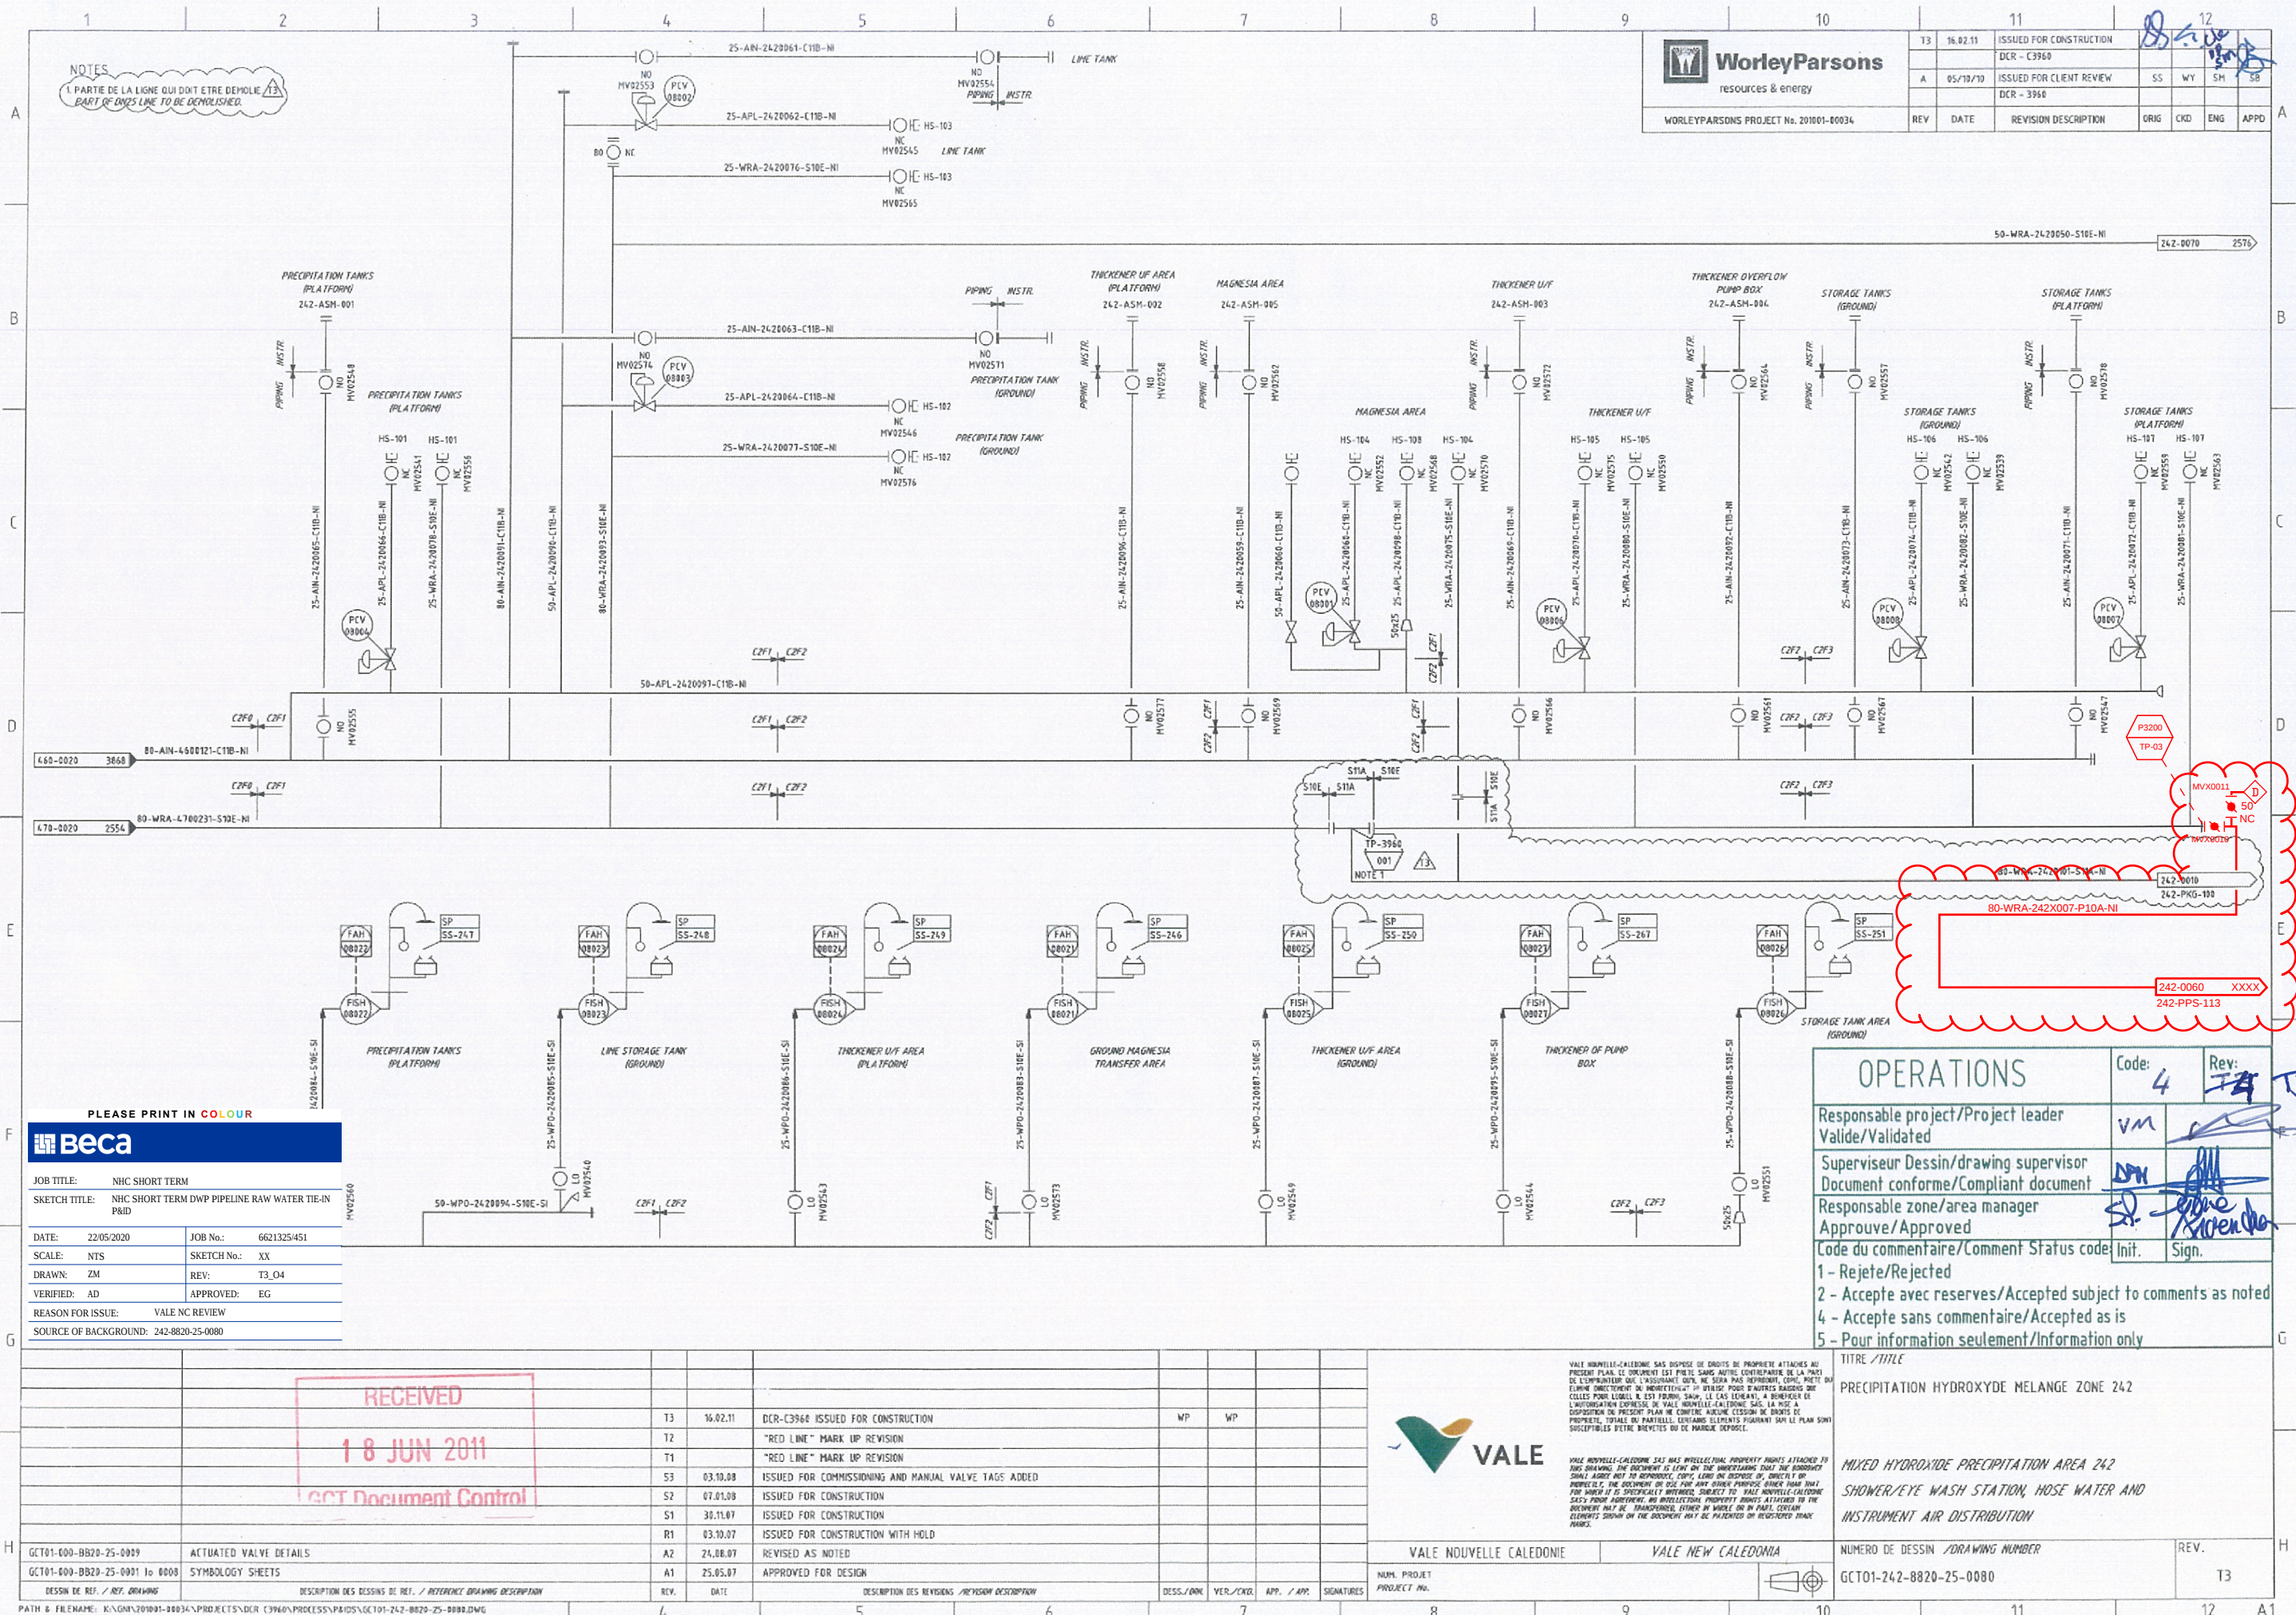